

NOTES

HI-MAX VIET NAM

THIET KE : HI-MAX VIET NAM

GIAM SAT : HI-MAX VIET NAM

**FOR APPROVAL**

REV.	DATE	DESCRIPTION	DRWN	DESN	CHKD	APPD	APPD


Project Name  
**HI-MAX VIET NAM**

 **HI-MAX VIET NAM CO., LTD**

 **HI-MAX VIET NAM CO., LTD**  
Lo B5F, KCN Hiep Phuoc, Nha Be, Tp.HCM

Title **EMERGENCY EXIT LIGHT (MEDIUM) (HL3113-1)**

Project No.	Drawing Number	Rev.
HI-MAX		
Part Fire Alarm System	Scale -	Microfilm No.

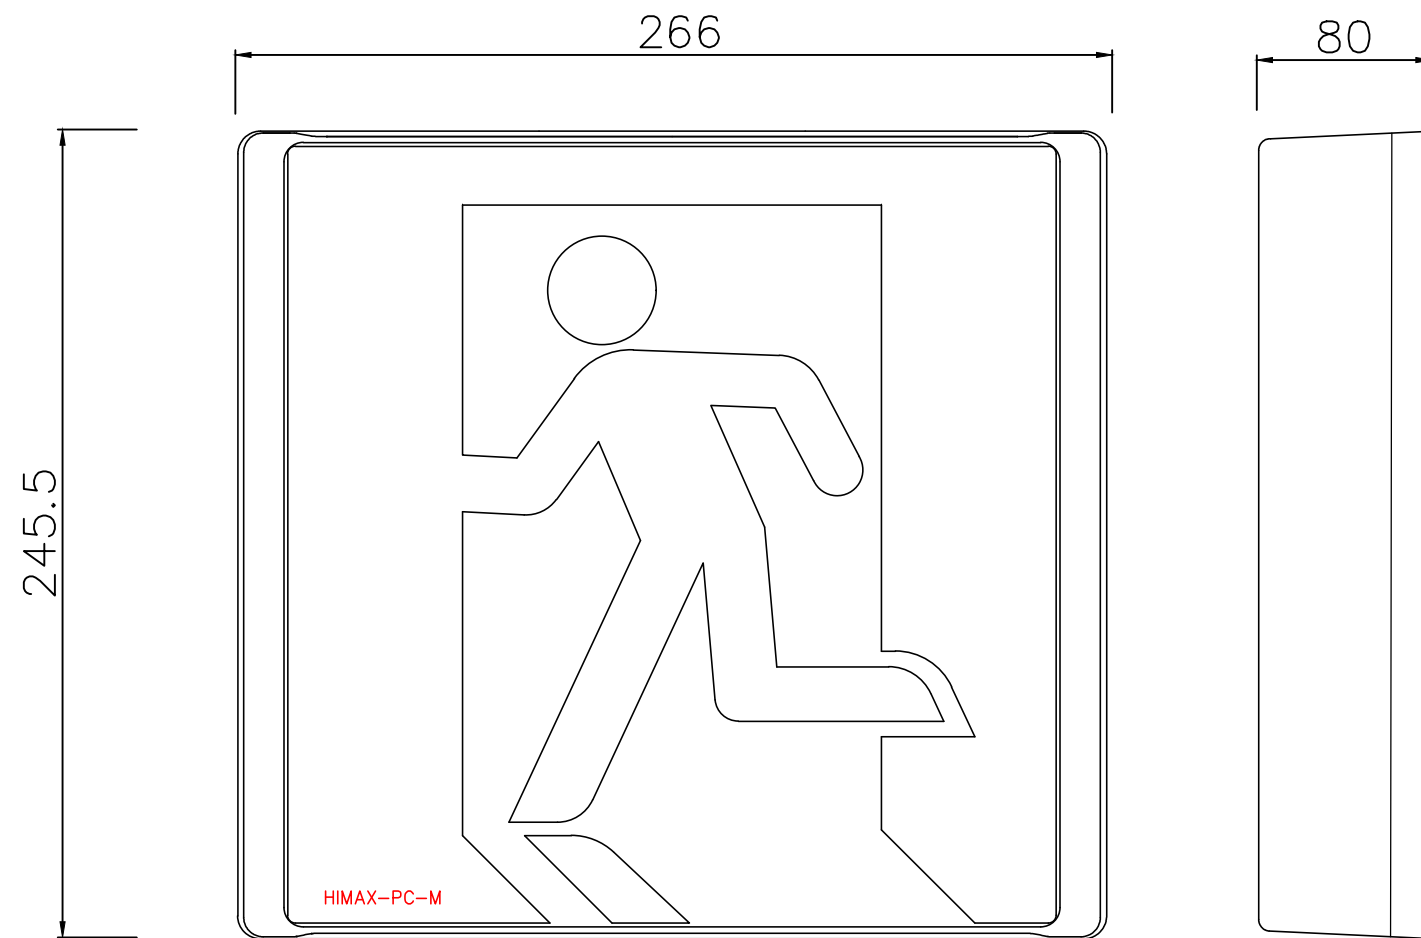

MODEL NO.	HL3113 - 1
TYPE	MEDIUM (BOTH SIDES)
RATED VOLTAGE POWER	AC220V / 3.8W
STAND-BY POWER	4.8V, 600mAh Ni-cd battery
STAND-BY TIME	MIN 60 MINUTES
SIZE / WEIGHT	W266mm x H244.5mm x D80mm / 1.3kg
APPLICATION	KITCHEN / BOILER ROOM / WELDING WORKSHOP / DRY ROOM / SEWAGE DISPOSAL PLANT / PROJECTION ROOM / CONFERENCE ROOM / KARAOKE / BASEMENT / TERMINAL / WAREHOUSE / RESTAURANT / DEPARTMENT STORE / HOTEL ROOM / COMPUTER ROOM