


NOTES

HI-MAX VIET NAM

THIET KE : HI-MAX VIET NAM

GIAM SAT : HI-MAX VIET NAM

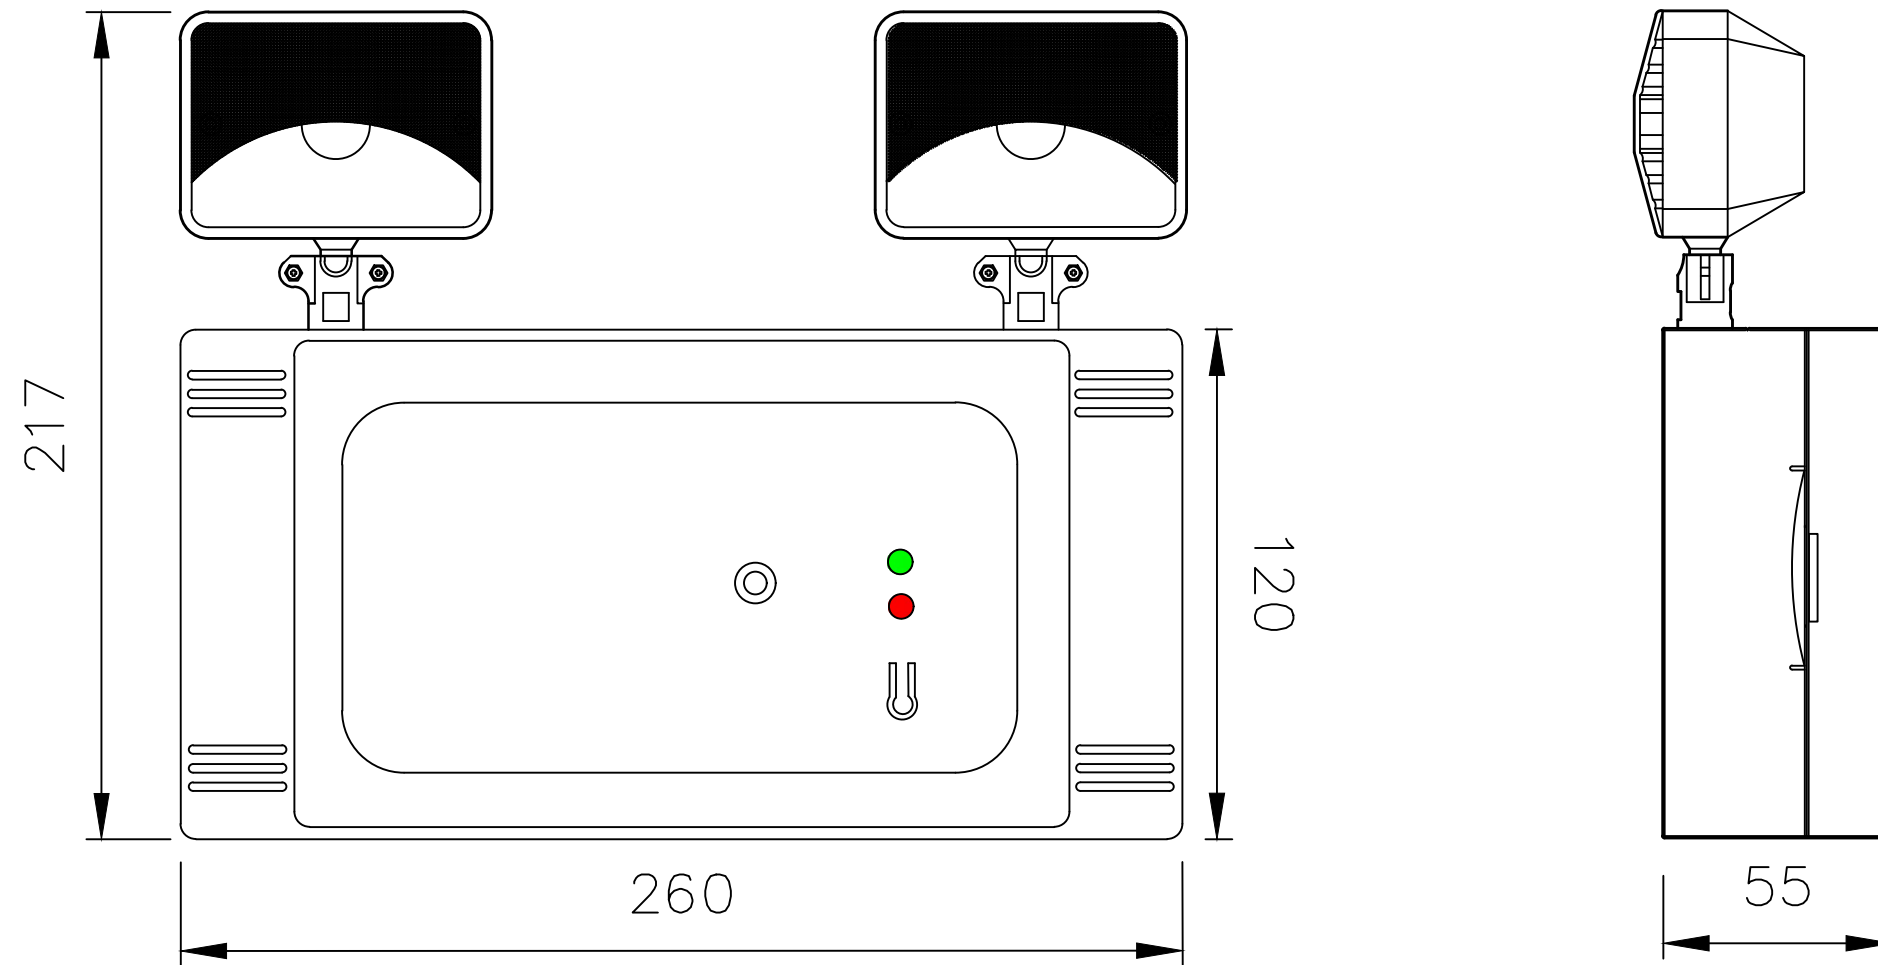

MODEL NO.	KOREA
TYPE	LED
RATED VOLTAGE POWER	AC 220V / DC 3.6V
OUT SIDE MATERIAL	GALVANIZED STEEL
STANB-BY TIME	MIN 60 MINUTES
POWER CONSUMPTION	2W
SIZE / WEIGHT	W260mm x H217mm x D55mm / 592g

FOR APPROVAL

REV.	DATE	DESCRIPTION	DRWN	DESN	CHKD	APPD	APPD
------	------	-------------	------	------	------	------	------

Project Name
HI-MAX VIET NAM

 **HI-MAX VIET NAM CO., LTD**

 **HI-MAX VIET NAM CO., LTD**
Lo B5F, KCN Hiep Phuoc, Nha Be, Tp.HCM

Title
EMERGENCY LIGHT (KOREA)

Project No. Drawing Number Rev.

HI-MAX

Part Fire Alarm System Scale - Microfilm No.