


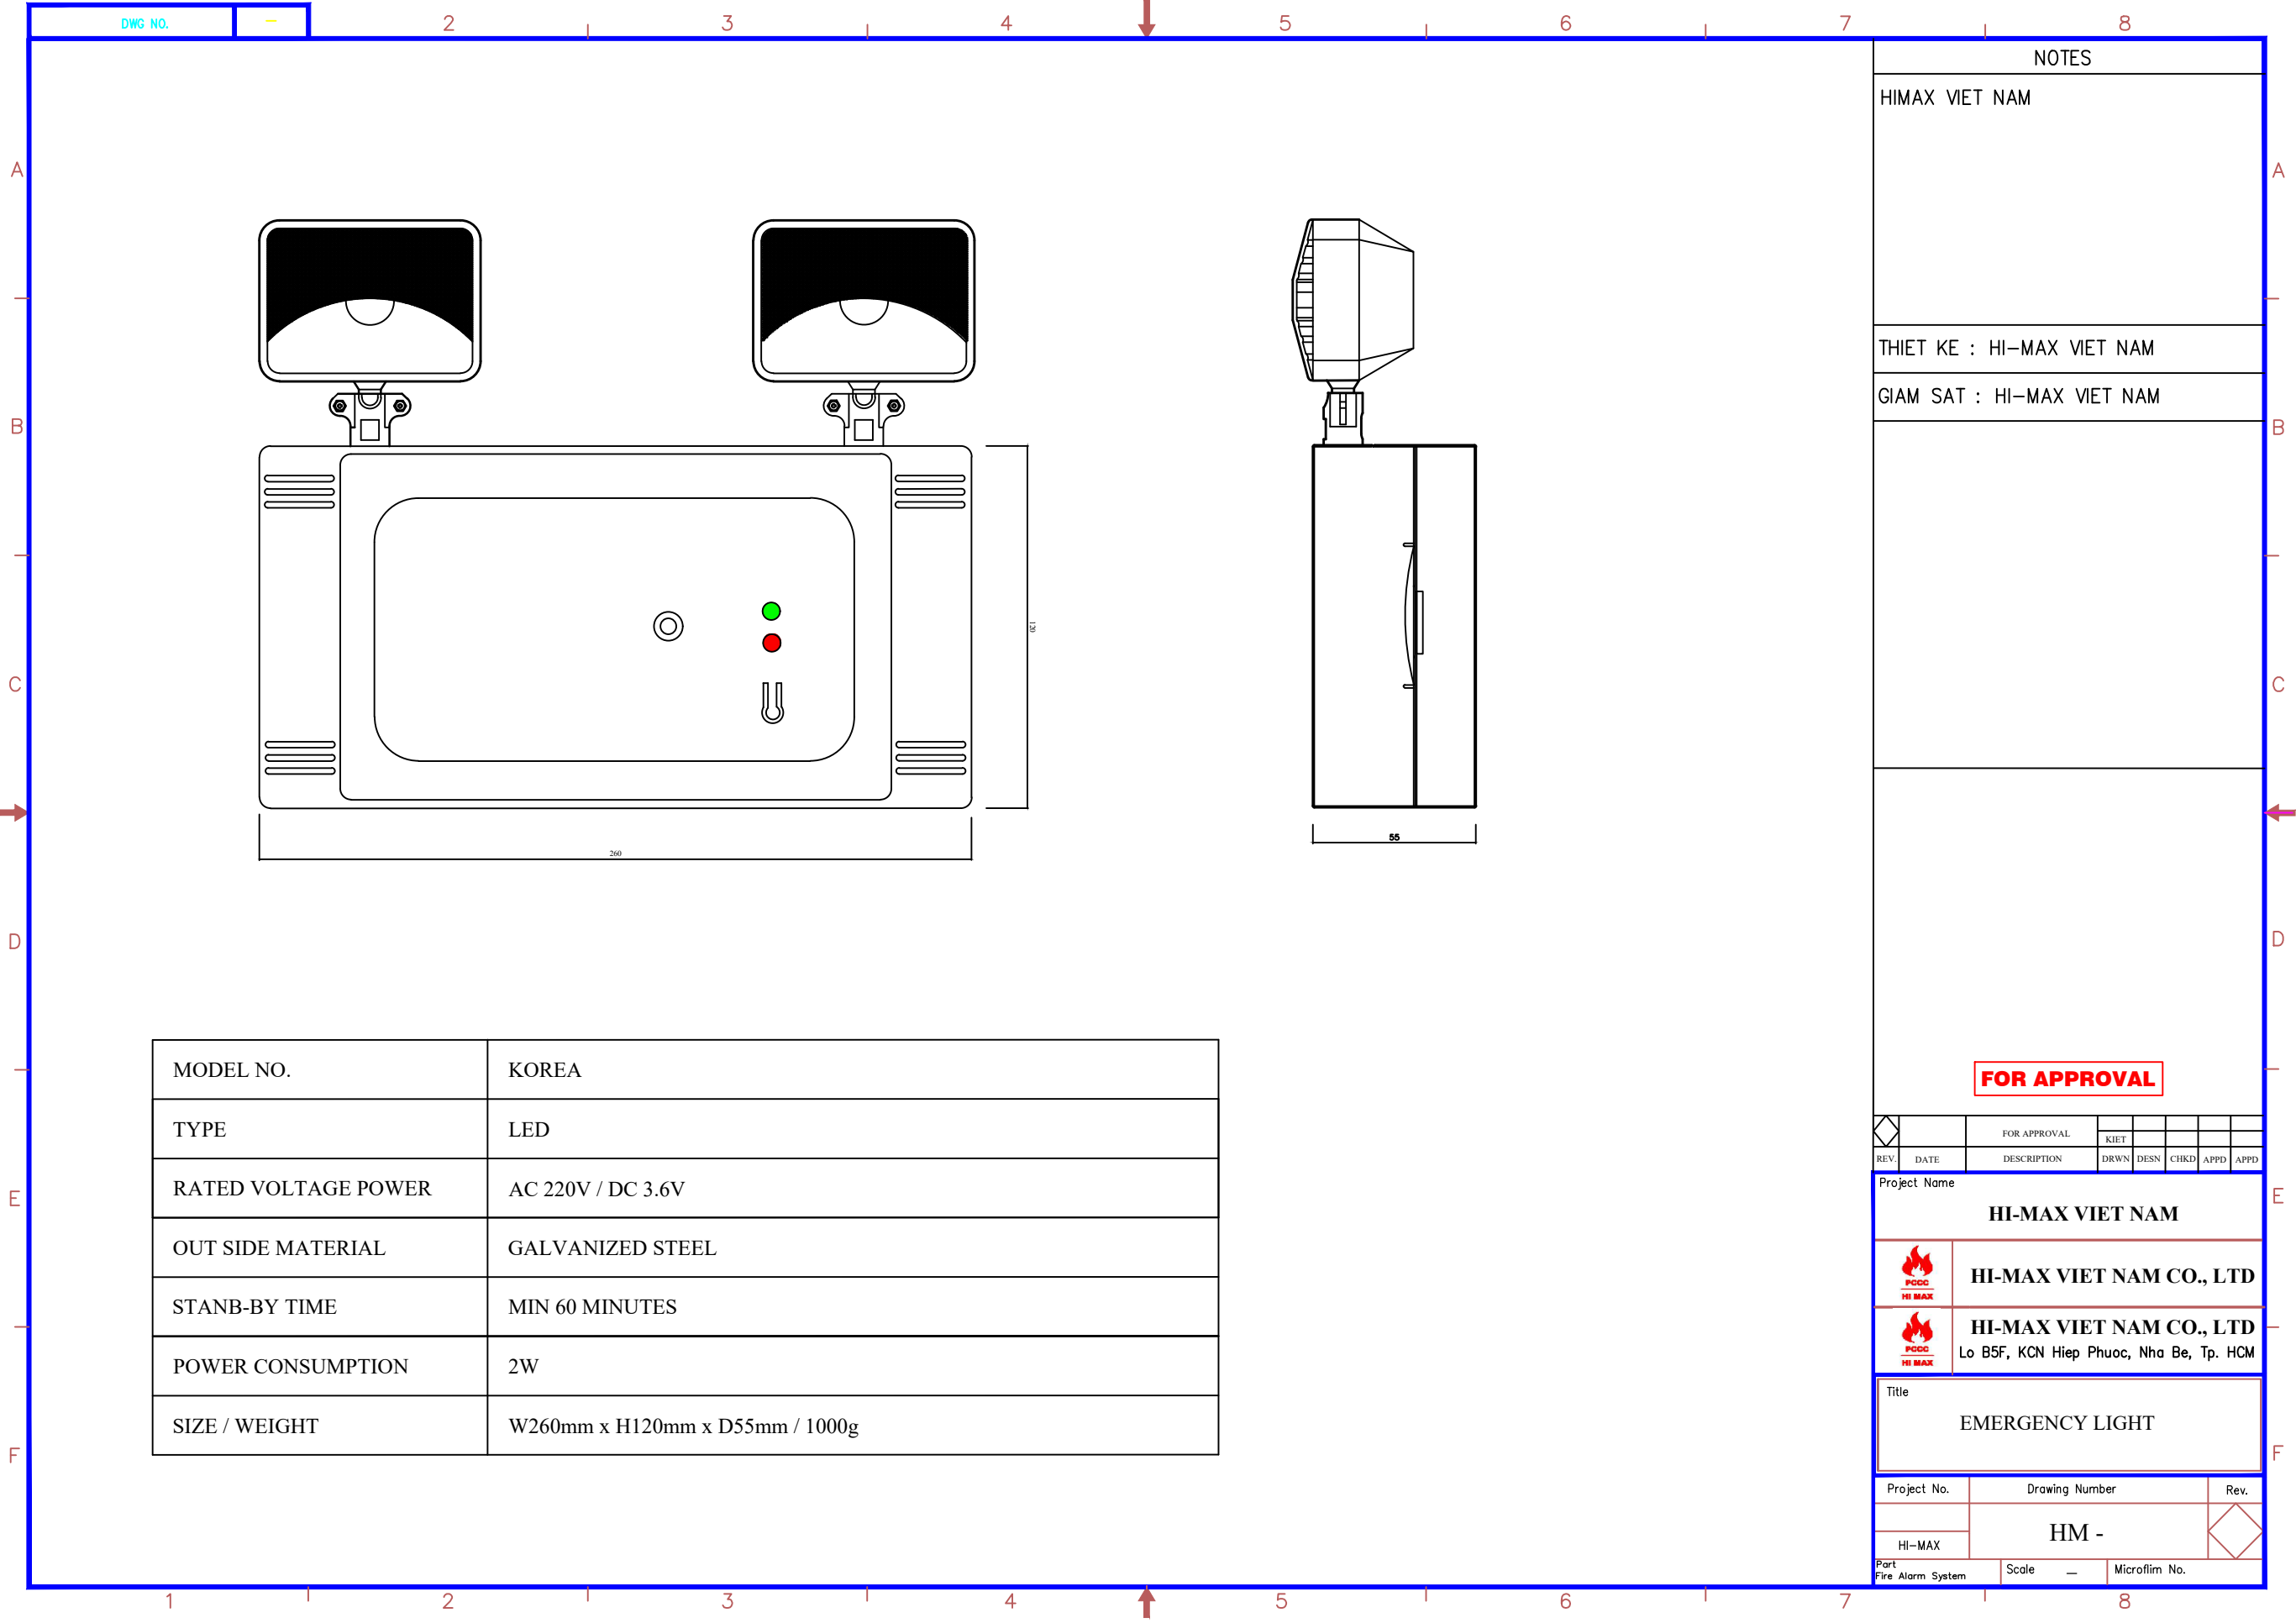

NOTES

HIMAX VIET NAM

THIET KE : HI-MAX VIET NAM

GIAM SAT : HI-MAX VIET NAM

FOR APPROVAL

REV.	DATE	DESCRIPTION	DRWN	DESN	CHKD	APPD	APPD
Project Name							
HI-MAX VIET NAM							
		HI-MAX VIET NAM CO., LTD					
		HI-MAX VIET NAM CO., LTD Lo B5F, KCN Hiep Phuoc, Nha Be, Tp. HCM					
Title							
EMERGENCY LIGHT							
Project No.		Drawing Number				Rev.	
HI-MAX		HM -					
Part Fire Alarm System		Scale —		Microfilm No.			